

---

# BRIDGETON LANDFILL

# 2020 Q4 INFRASTRUCTURE UPDATE


---

JANUARY 2021  
PREPARED FOR:

**BRIDGETON LANDFILL, LLC**  
13570 ST. CHARLES ROCK ROAD  
BRIDGETON, MISSOURI 63044




LOCATION MAP

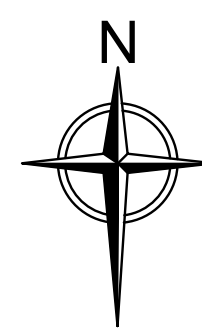


3377 HOLLENBERG DRIVE  
BRIDGETON, MO 63044  
TEL. (217) 483-3118

## INDEX OF DRAWINGS

	TITLE PAGE
001	FULL SITE PLAN VIEW W/ AERIAL
001A	FULL SITE PLAN VIEW W/ AERIAL - ALTERNATE VIEW
002	FULL SITE PLAN VIEW
003	2020 Q4 SITE INFRASTRUCTURE PLAN
004	2020 Q4 SITE INFRASTRUCTURE - UPDATES IN Q4 SHOWN IN COLOR
005	2020 Q4 SITE INFRASTRUCTURE - REMOVED IN Q4 SHOWN IN COLOR

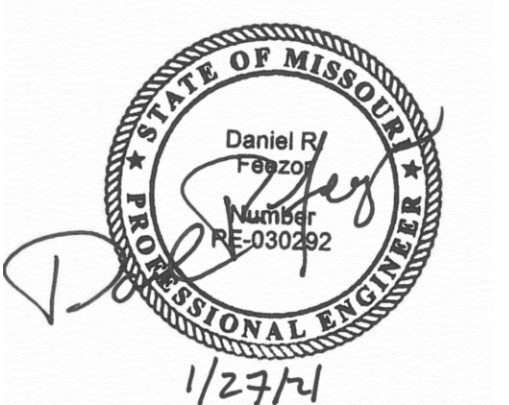

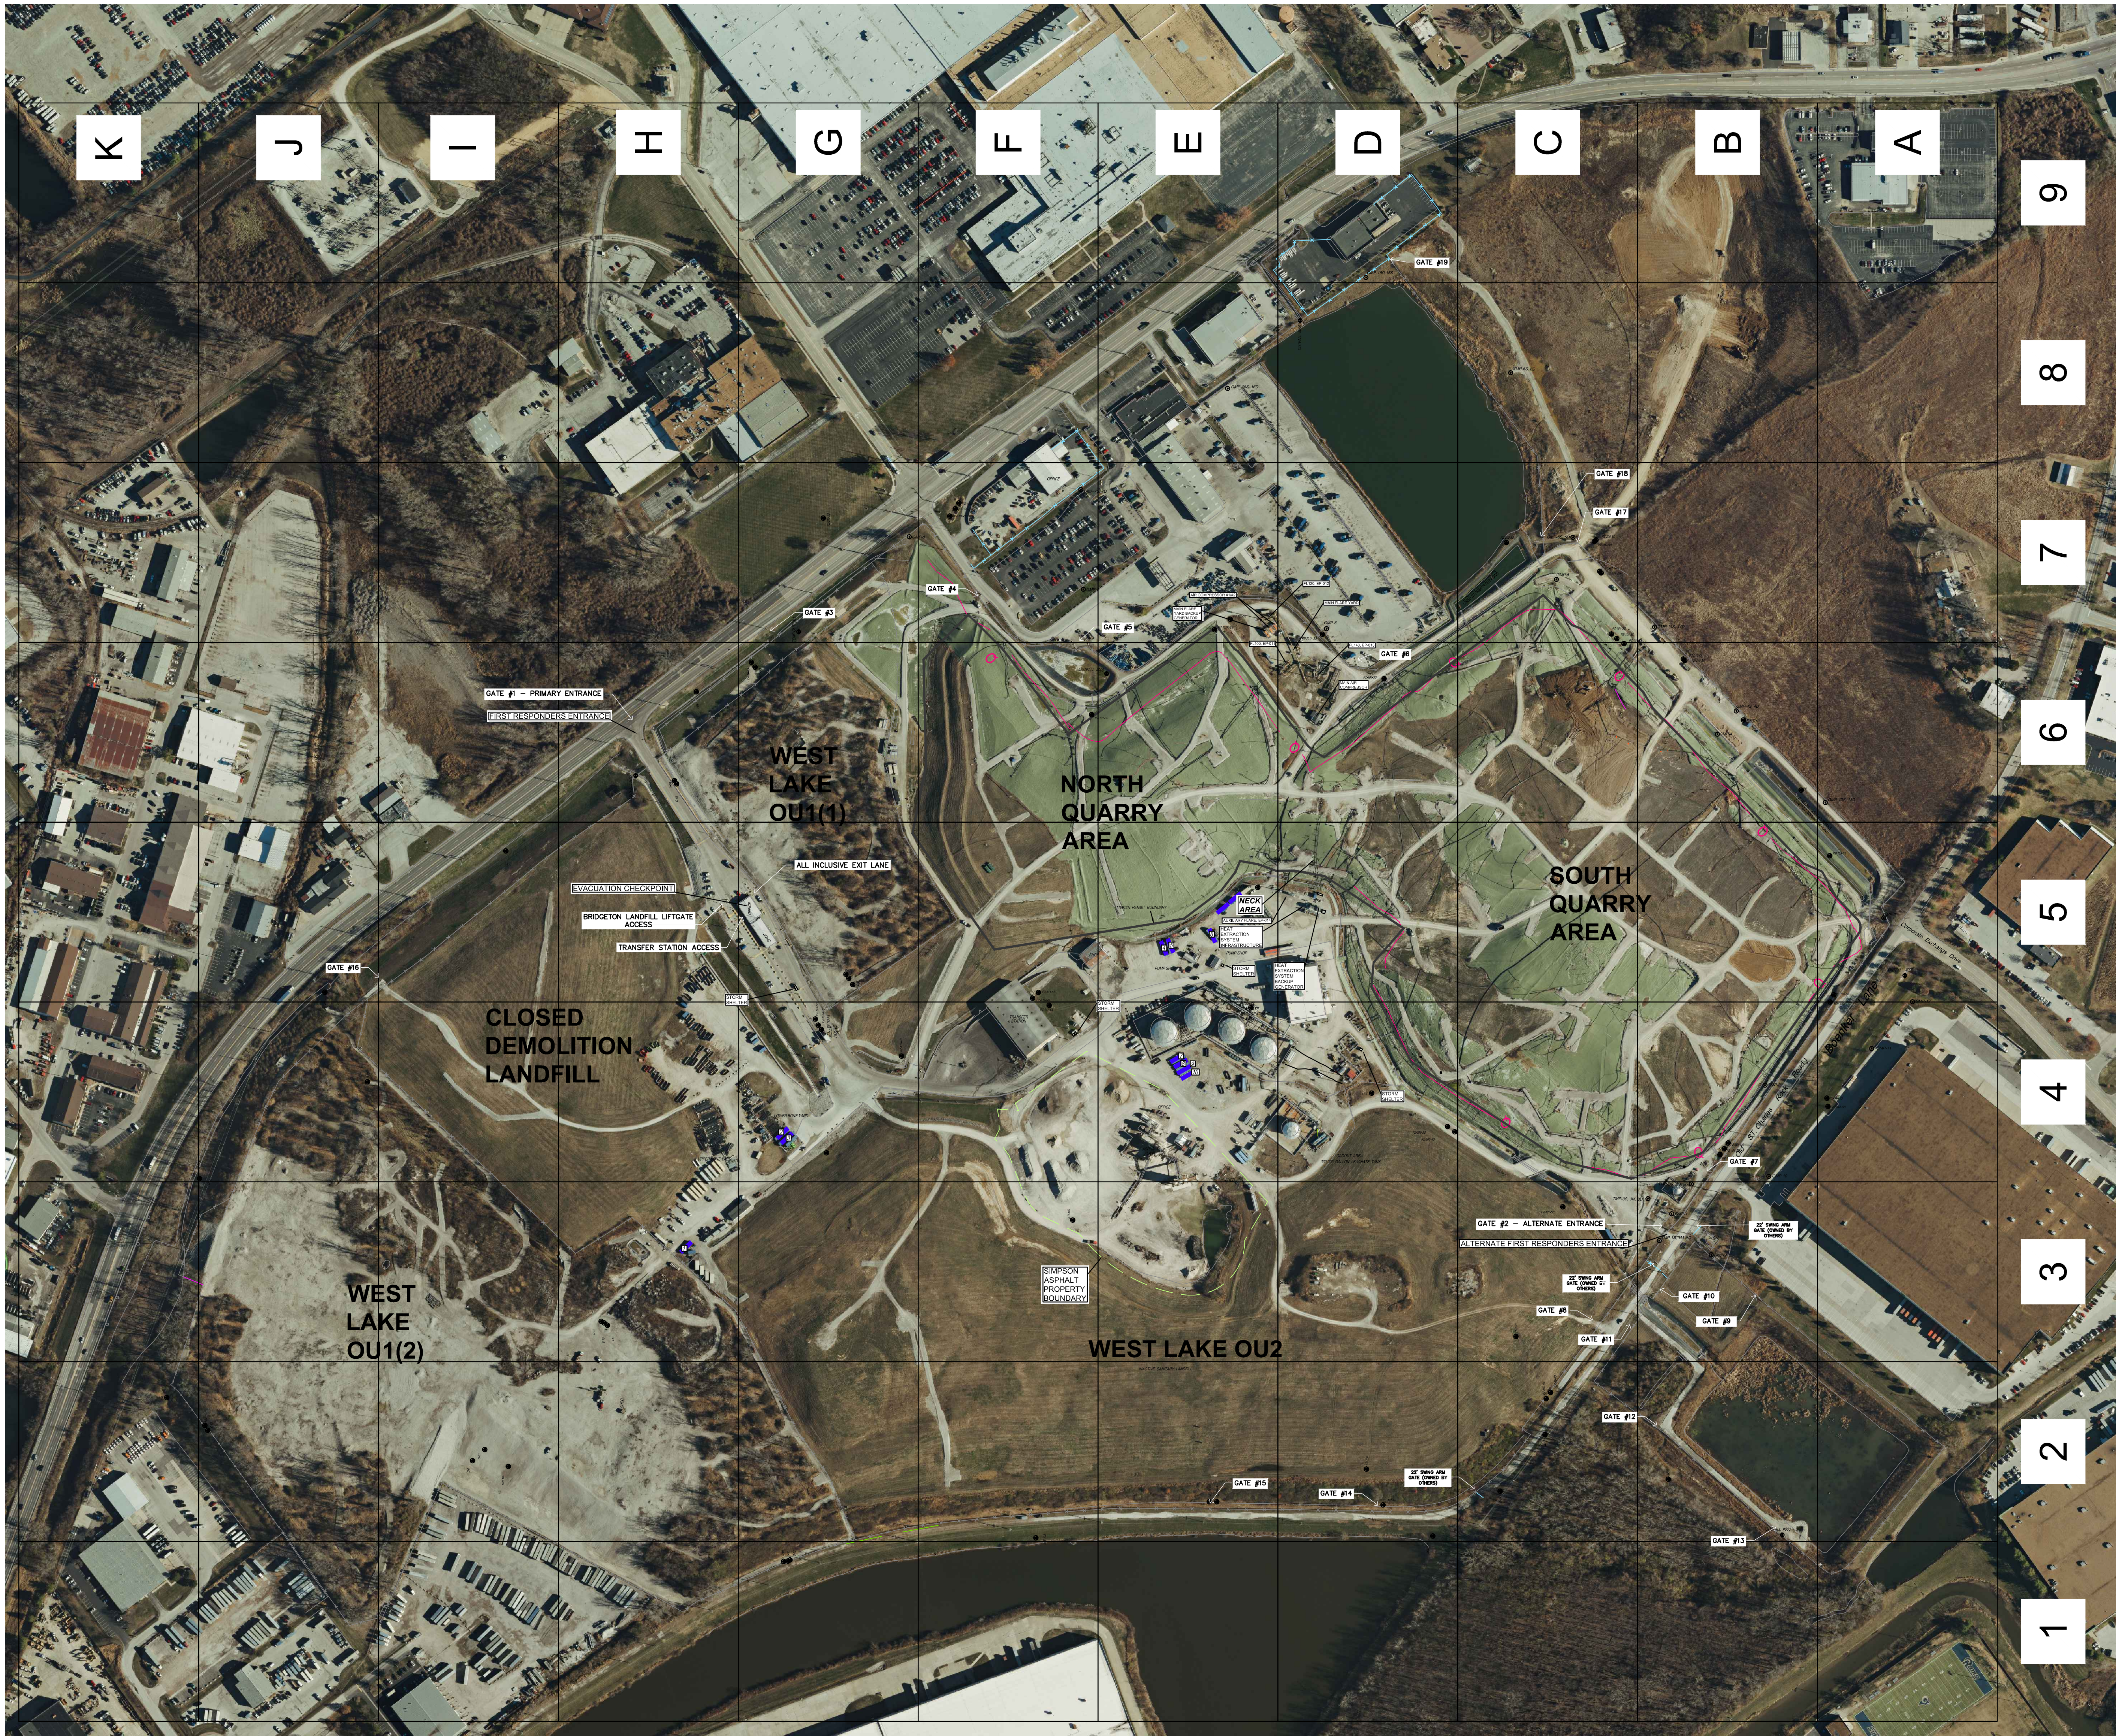


**LEGEND**

	SOLID WASTE BOUNDARY
	QUARRY WALL
	FENCE LINE
	GAS MONITORING PROBE
	PIEZOMETER MONITORING WELL

**NOTES:**  
 \* AERIAL TOPOGRAPHY AND PHOTOGRAPHY PROVIDED BY COOPER AERIAL SURVEYS CO. AND IS DATED DECEMBER 9, 2020.

**DISCLAIMER:**  
 THE EXISTENCE AND APPROXIMATE LOCATION OF UTILITIES KNOWN TO EXIST, AS SHOWN ON THESE DRAWINGS ARE BASED ON THE BEST INFORMATION PROVIDED TO FEI AT THE TIME OF THIS SUBMITTAL. THIS INFORMATION HAS BEEN PROVIDED TO FEI "AS-IS" AND FEI EXPRESSLY DISCLAIMS ANY REPRESENTATION OR WARRANTY AS TO THE COMPLETENESS OR ACCURACY OF THE INFORMATION FOR ANY USE. IT IS THE RESPONSIBILITY OF ANY PARTIES PERFORMING WORK TO VERIFY THE EXISTENCE, LOCATION AND STATUS OF ANY FACILITY. SUCH VERIFICATION INCLUDES DIRECT CONTACT WITH THE LISTED UTILITIES.

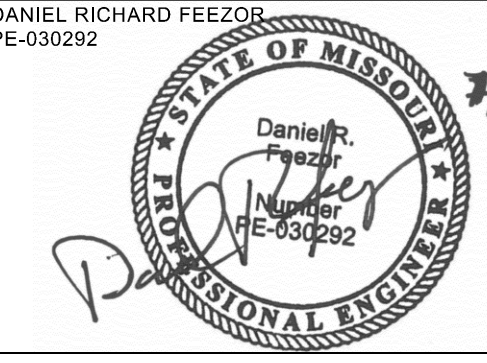


PREPARED BY: DANIEL RICHARD FEEZOR PE-030292	PROJECT: BRIDGETON LANDFILL 2020 Q4 INFRASTRUCTURE SUBMITTAL BRIDGETON, ST. LOUIS COUNTY, MO	PREPARED FOR: BRIDGETON LANDFILL, LLC 13570 ST. CHARLES ROCK ROAD BRIDGETON, MISSOURI 63044	JANUARY 2021 DESIGNED BY: AMR APPROVED BY: DRF	<b>DRAWING #</b> <b>001</b>												
<b>DRAWING TITLE</b> <b>FULL SITE PLAN VIEW W/ AERIAL</b>				<b>REVISIONS:</b>												
				<table border="1"> <thead> <tr> <th>DATE</th> <th>DSN</th> <th>APV.</th> </tr> </thead> <tbody> <tr> <td> </td> <td> </td> <td> </td> </tr> <tr> <td> </td> <td> </td> <td> </td> </tr> <tr> <td> </td> <td> </td> <td> </td> </tr> </tbody> </table>	DATE	DSN	APV.									
DATE	DSN	APV.														
PROJECT NUMBER: BT-130211 FILE PATH: C:\Users\amr\Desktop\Bridgeton Landfill\Drawings\2020 Q4\2020 Q4 Infrastructure\0011 - 0110 - 0000.dwg																




**LEGEND**

	SOLID WASTE BOUNDARY
	QUARRY WALL
	FENCE LINE
	GAS MONITORING PROBE
	PIEZOMETER MONITORING WELL

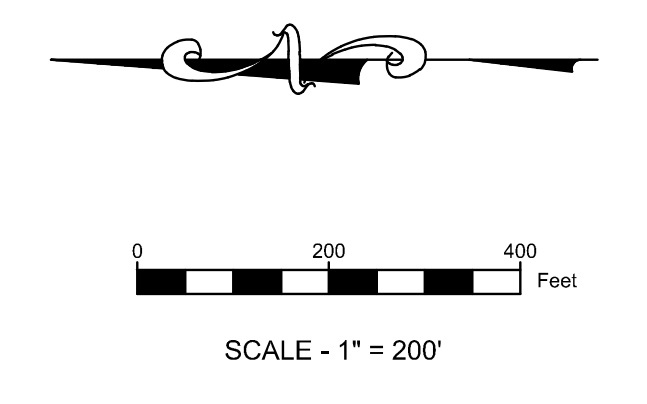


**NOTES:**  
 \* AERIAL TOPOGRAPHY AND PHOTOGRAPHY PROVIDED BY COOPER AERIAL SURVEYS CO. AND IS DATED DECEMBER 9, 2020.

**DISCLAIMER:**  
 THE EXISTENCE AND APPROXIMATE LOCATION OF UTILITIES KNOWN TO EXIST, AS SHOWN ON THESE DRAWINGS ARE BASED ON THE BEST INFORMATION PROVIDED TO FEI AT THE TIME OF THIS SUBMITTAL. THIS INFORMATION HAS BEEN PROVIDED TO FEI "AS-IS" AND FEI EXPRESSLY DISCLAIMS ANY REPRESENTATION OR WARRANTY AS TO THE COMPLETENESS OR ACCURACY OF THE INFORMATION FOR ANY USE. IT IS THE RESPONSIBILITY OF ANY PARTIES PERFORMING WORK TO VERIFY THE EXISTENCE, LOCATION AND STATUS OF ANY FACILITY. SUCH VERIFICATION INCLUDES DIRECT CONTACT WITH THE LISTED UTILITIES.

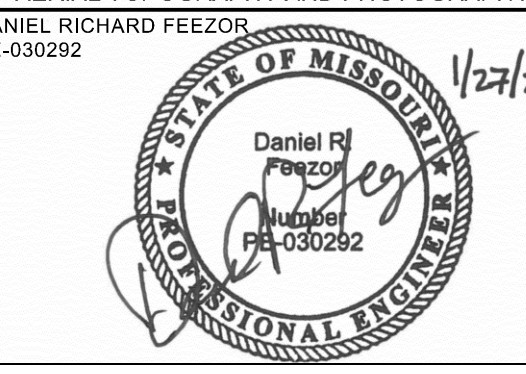


PROJECT	BRIDGETON LANDFILL 2020 Q4 INFRASTRUCTURE SUBMITTAL BRIDGETON, ST. LOUIS COUNTY, MO	PREPARED BY	BRIDGETON LANDFILL, LLC 13570 ST. CHARLES ROCK ROAD BRIDGETON, MISSOURI 63044	DESIGNED BY: AMR APPROVED BY: DRF	DRAWING #	<b>001A</b>	
DRAWING TITLE	<b>FULL SITE PLAN VIEW W/ AERIAL</b>			REVISIONS:	DATE	DSN	APV.
PROJECT NUMBER: BT-130211 FILE PATH: C:\Users\amr\Desktop\Feezor\Drawings\Bridgeton\19-10881-08 Quarry Infrastructure\0011 - 01-10-2020.dwg							

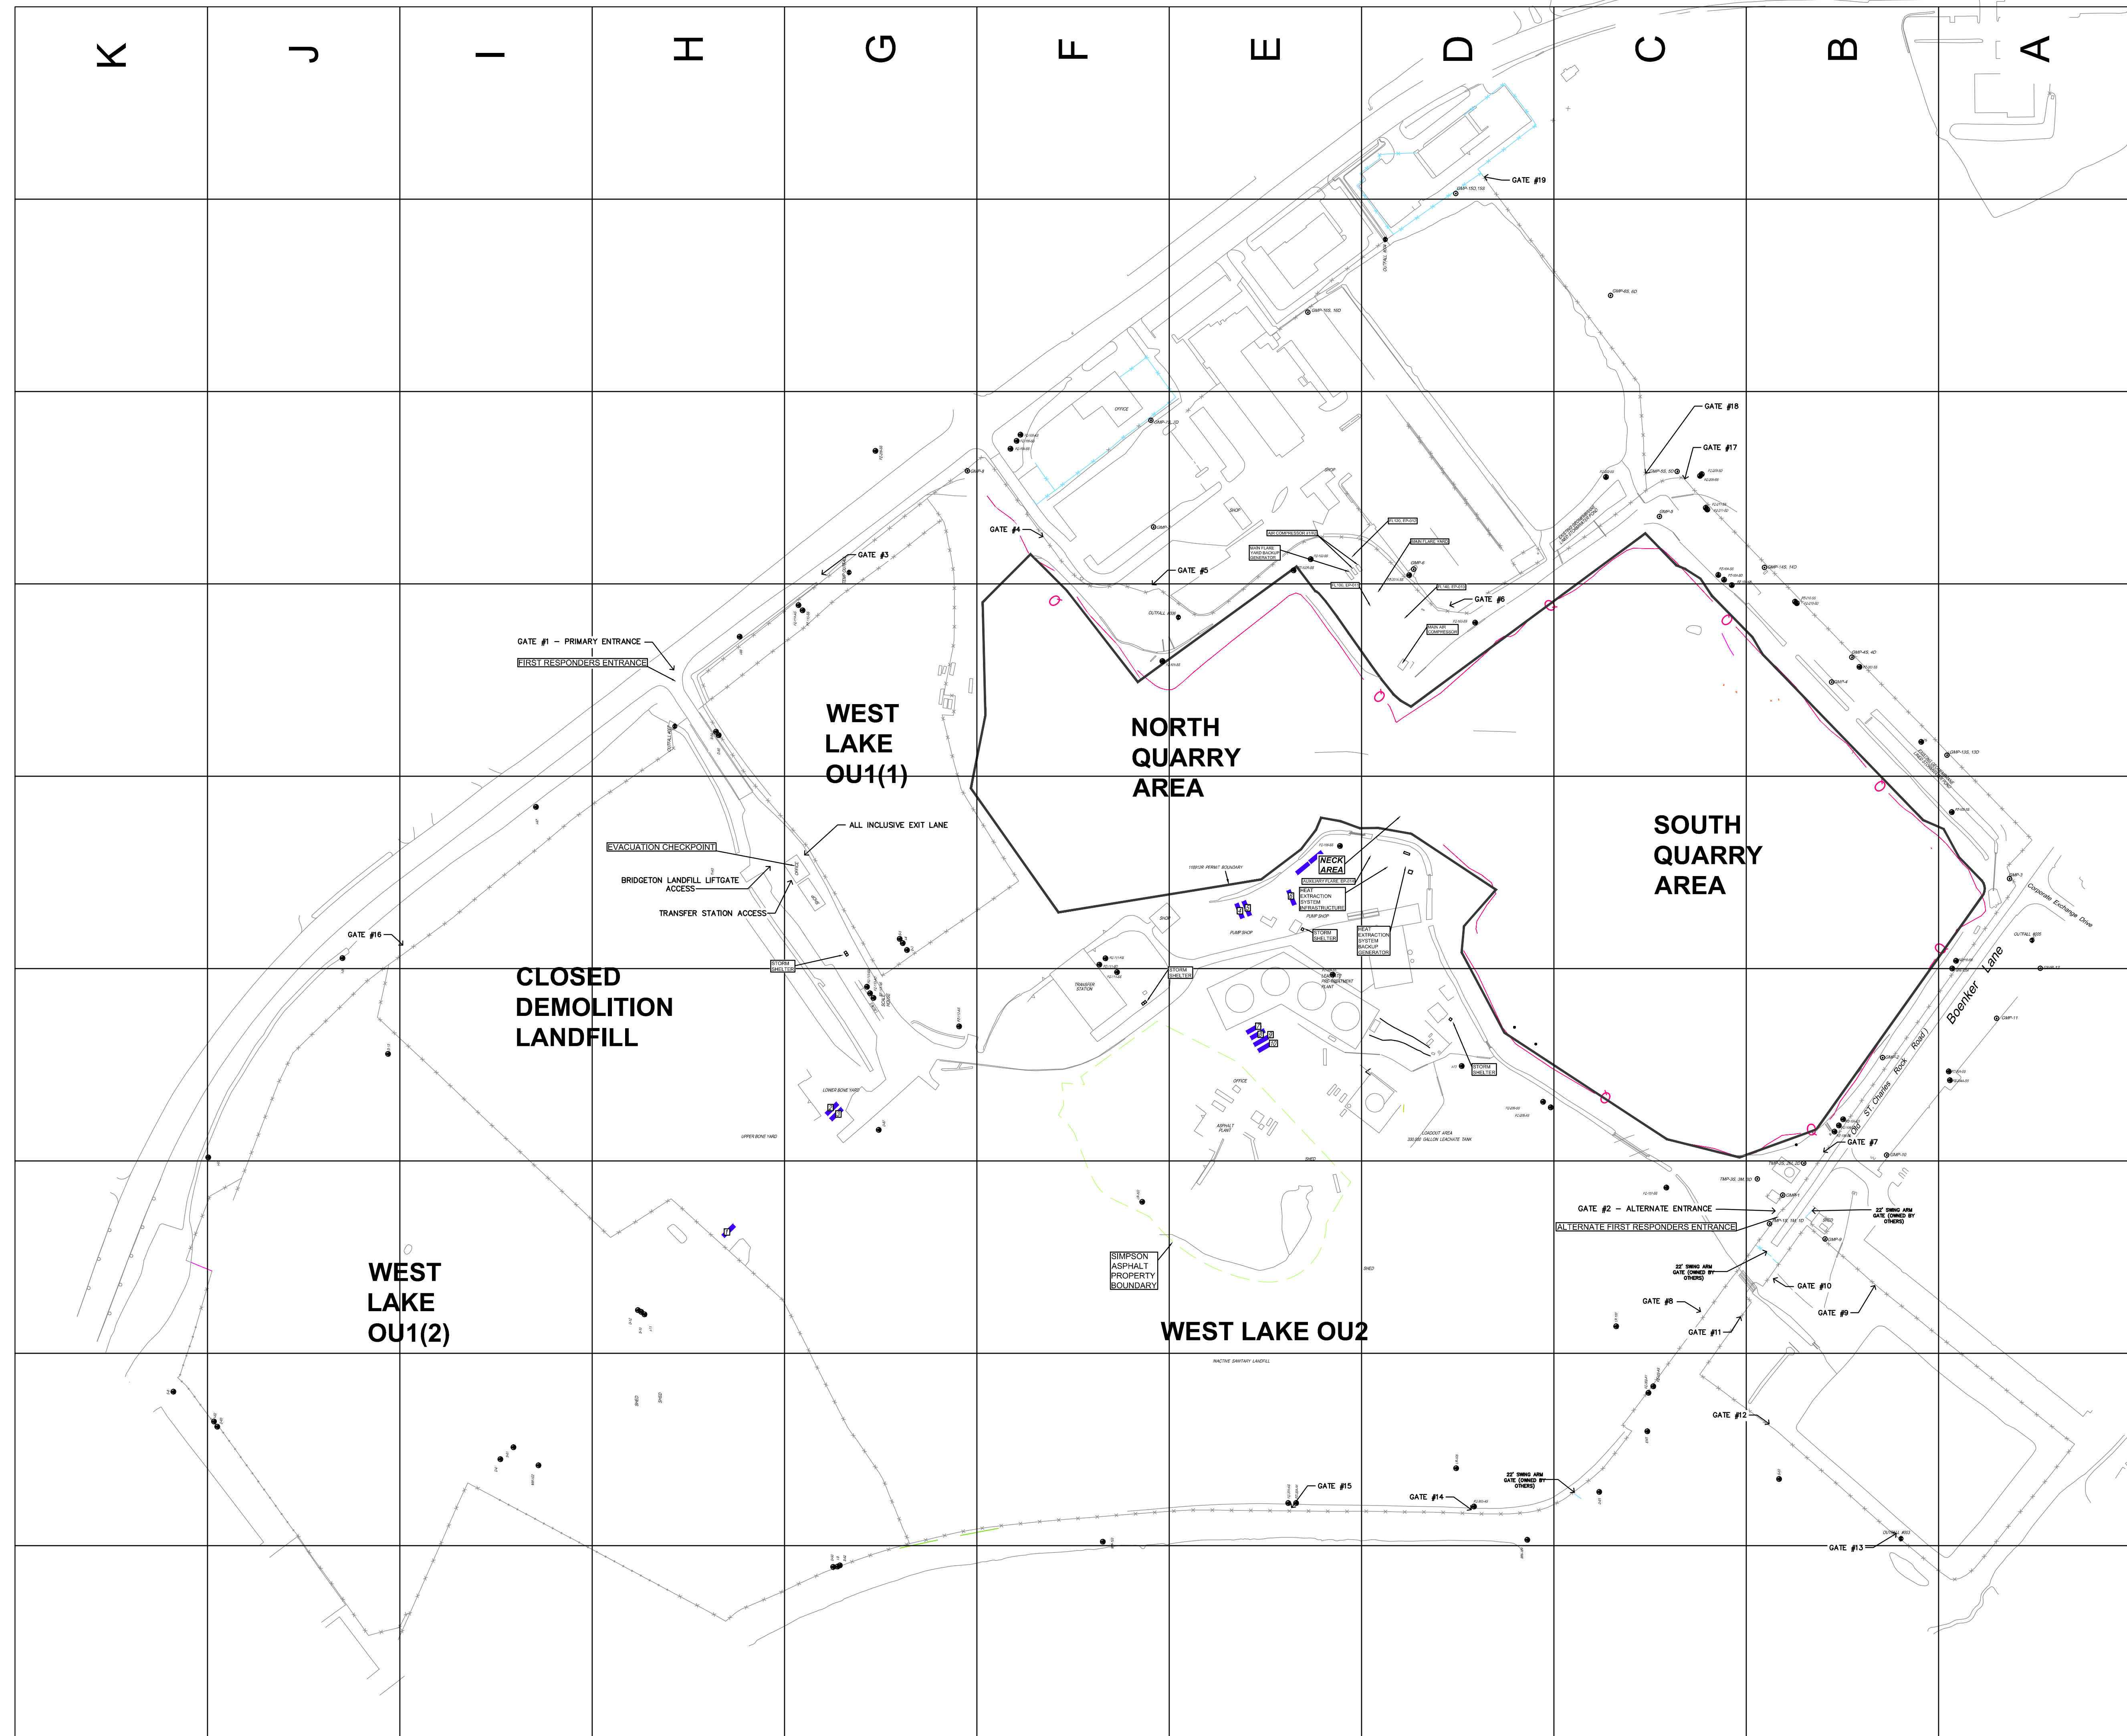

**LEGEND**


	SOLID WASTE BOUNDARY
	QUARRY WALL
	FENCE LINE
	GAS MONITORING PROBE
	PIEZOMETER MONITORING WELL

9  
8  
7  
6  
5  
4  
3  
2  
1

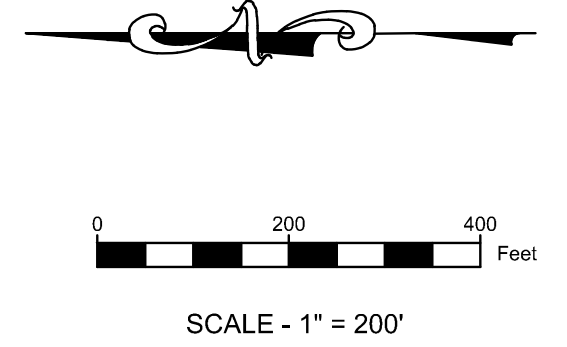

**NOTES:**  
 \* AERIAL TOPOGRAPHY AND PHOTOGRAPHY PROVIDED BY COOPER AERIAL SURVEYS CO. AND IS DATED DECEMBER 9, 2020.  
 DANIEL RICHARD FEEZOR  
 PE-030292

**DISCLAIMER:**  
 THE EXISTENCE AND APPROXIMATE LOCATION OF UTILITIES KNOWN TO EXIST, AS SHOWN ON THESE DRAWINGS ARE BASED ON THE BEST INFORMATION PROVIDED TO FEI AT THE TIME OF THIS SUBMITTAL. THIS INFORMATION HAS BEEN PROVIDED TO FEI "AS-IS" AND FEI EXPRESSLY DISCLAIMS ANY REPRESENTATION OR WARRANTY AS TO THE COMPLETENESS OR ACCURACY OF THE INFORMATION FOR ANY USE. IT IS THE RESPONSIBILITY OF ANY PARTIES PERFORMING WORK TO VERIFY THE EXISTENCE, LOCATION AND STATUS OF ANY FACILITY. SUCH VERIFICATION INCLUDES DIRECT CONTACT WITH THE LISTED UTILITIES.

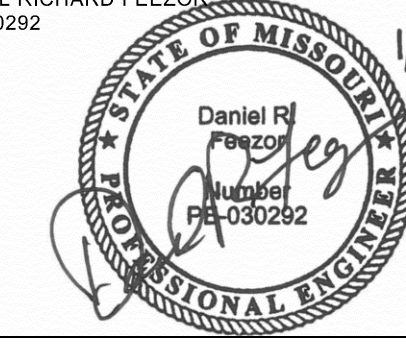


PROJECT	BRIDGETON LANDFILL 2020 Q4 INFRASTRUCTURE SUBMITTAL BRIDGETON, ST. LOUIS COUNTY, MO	PREPARED FOR	BRIDGETON LANDFILL, LLC 13570 ST. CHARLES ROCK ROAD BRIDGETON, MISSOURI 63044	DESIGNED BY: AMR APPROVED BY: DRF	DATE	DSN	APV.	DRAWING #	<b>002</b>
DRAWING TITLE	<b>FULL SITE PLAN VIEW</b>								
PROJECT NUMBER	BT-130211 FILE PATH: C:\Users\amr\Desktop\Drawings\2020\202004\20200409-10-14881-10\20200409-10-14881-10.dwg								



**LEGEND**

○ CMP-4	SOLID WASTE BOUNDARY
● P2-204-AS	GAS MONITORING PROBE
● GEW-38	PIEZOMETER MONITORING WELL
▲ ITS1	GAS EXTRACTION WELL
● SEW-63	INTERCEPTOR TRENCH SUMP
● PEH-20	SURFACE EXTRACTION WELL
○	PERIMETER GAS EXTRACTION WELL
○	LFG ISOLATION VALVE
○	LEACHATE ISOLATION VALVE
○	FLOW METER
○	GRIT CHAMBER
○	LIFT STATION
○	CONDENSATE SUMP
○	CONDENSATE TRAP/HEADER CONNECTION SUMP
○	LEACHATE COLLECTION SUMP
○	HORIZONTAL COLLECTION SUMP
○	PERIMETER SUMP
○	LEACHATE COLLECTION SUMP
○	SURFACE COLLECTOR
○	TEMPERATURE MONITORING PROBE
○	SUBSURFACE RCP WELLS
○	TRENCH SUMP
○	INTERCEPTION TRENCH RISER
○	PERIMETER LEACHATE SUMP
○	WELL HEAD RISER
○	WELL BORE BOOT
○	TRENCH SUMP
○	OVER LINER TIE IN POINT
○	GAS INTERCEPTOR WELL
○	GAS INTERCEPTOR WELL/HEAT EXTRACTION POINT
○	CLEAN OUT
○	GAS EXTRACTION WELL WITH 4" STINGER
○	EXTRACTION POINT - ABANDONED
○	EXTRACTION POINT - TEMPORARILY DECOMMISSIONED
○	CONTAINMENT SUMP PUMP STATION FOR TOE STRIP DRAIN
○	DOWNSLOPE STRIP DRAIN COLLECTOR 6" RISER STUB
○	QUADRANT #
○	POWER PANEL
○	THERMOCOUPLE
○	QUARRY WALL
○	LEACHATE COLLECTION PIPING
○	DUAL CONTAINED LCS FORCEMAIN (SIZE VARIES)
○	DUAL CONTAINED PERIMETER FORCEMAIN (SIZE VARIES)
○	LEACHATE COLLECTION PIPING (SIZE VARIES)
○	TOE DRAIN
○	4" PERFORATED TRENCH DRAIN
○	BUBBLE SUCKER
○	AIR LINE (PRESSURIZED BELOW GROUND)
○	BURIED LFG COLLECTION PIPING (SIZE VARIES)
○	2" ABOVE GROUND LFG COLLECTION LATERAL PIPING
○	4" ABOVE GROUND LFG COLLECTION LATERAL PIPING
○	6" ABOVE GROUND LFG COLLECTION LATERAL PIPING
○	8" ABOVE GROUND LFG COLLECTION LATERAL PIPING
○	10" ABOVE GROUND LFG COLLECTION LATERAL PIPING
○	12" ABOVE GROUND LFG COLLECTION LATERAL PIPING
○	18" ABOVE GROUND LFG COLLECTION HEADER PIPING
○	24" ABOVE GROUND LFG COLLECTION LATERAL PIPING
○	2" PRESSURIZED AIR / 2" FORCEMAIN IN COMMON TRENCH
○	ABOVEGROUND ELECTRIC LINE
○	UNDERGROUND ELECTRIC LINE
○	SANITARY SEWER
○	MSD DISCHARGE FORCEMAIN
○	WATERMAIN
○	NATURAL GAS LINE
○	PROPANE GAS LINE
○	FIBER OPTIC LINE
○	TELEPHONE
○	FENCE LINE
○	INTERCEPTOR TRENCH
○	HEAT EXTRACTION EFFLUENT PIPING
○	HEAT EXTRACTION INFLUENT PIPING

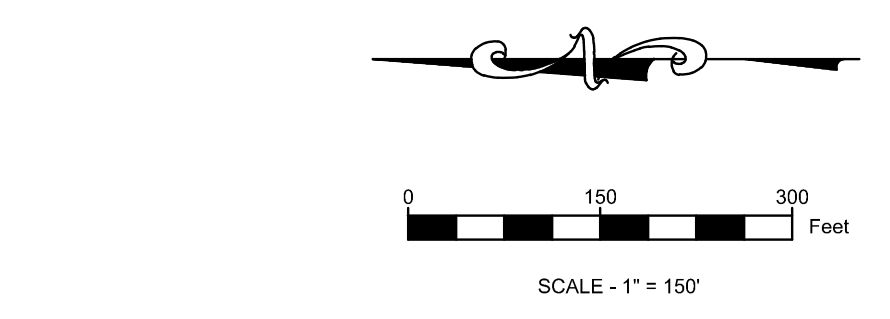

**NOTES:**  
 \* AERIAL TOPOGRAPHY AND PHOTOGRAPHY PROVIDED BY COOPER AERIAL SURVEYS CO. AND IS DATED DECEMBER 9, 2020.


**DISCLAIMER:**  
 THE EXISTENCE AND APPROXIMATE LOCATION OF UTILITIES KNOWN TO EXIST, AS SHOWN ON THESE DRAWINGS ARE BASED ON THE BEST INFORMATION PROVIDED TO FEI AT THE TIME OF THIS SUBMITTAL. THIS INFORMATION HAS BEEN PROVIDED TO FEI AS-IS AND FEI EXPRESSLY DISCLAIMS ANY REPRESENTATION OR WARRANTY AS TO THE COMPLETENESS OR ACCURACY OF THE INFORMATION FOR ANY USE. IT IS THE RESPONSIBILITY OF ANY PARTIES PERFORMING WORK TO VERIFY THE EXISTENCE, LOCATION AND STATUS OF ANY FACILITY. SUCH VERIFICATION INCLUDES DIRECT CONTACT WITH THE LISTED UTILITIES.

	PREPARED BY: DANIEL RICHARD FEEZOR PE-030292	PROJECT: BRIDGETON LANDFILL 2020 Q4 INFRASTRUCTURE SUBMITTAL BRIDGETON, ST. LOUIS COUNTY, MO	PREPARED FOR: BRIDGETON LANDFILL, LLC 13570 ST. CHARLES ROCK ROAD BRIDGETON, MISSOURI 63044	JANUARY 2021 DESIGNED BY: AMR APPROVED BY: DRF	DRAWING # <b>003</b>
		DRAWING TITLE: <b>2020 Q4 SITE INFRASTRUCTURE</b>	REVISIONS:	DATE	DSN

PROJECT NUMBER: BT-13021 | FILE PATH: C:\Users\amr\Desktop\Project\Bridgeton\2020Q4\2020Q4-01\2020Q4-01-01-001.dwg




LEGEND	
	SOLID WASTE BOUNDARY
	GAS MONITORING PROBE
	PIEZOMETER MONITORING WELL
	GAS EXTRACTION WELL
	INTERCEPTOR TRENCH SUMP
	SURFACE EXTRACTION WELL
	PERIMETER GAS EXTRACTION WELL
	LFG ISOLATION VALVE
	LEACHATE ISOLATION VALVE
	FLOW METER
	GRIT CHAMBER
	LIFT STATION
	CONDENSATE SUMP
	CONDENSATE TRAP/HEADER CONNECTION SUMP
	LEACHATE COLLECTION SUMP
	HORIZONTAL COLLECTION SUMP
	PERIMETER SUMP
	LEACHATE COLLECTION SUMP
	SURFACE COLLECTOR
	TEMPERATURE MONITORING PROBE
	SUBSURFACE RCP WELLS
	TRENCH SUMP
	INTERCEPTION TRENCH RISER
	PERIMETER LEACHATE SUMP
	WELL HEAD RISER
	WELL BORE BOOT
	TRENCH SUMP
	OVER LINER TIE IN POINT
	GAS INTERCEPTOR WELL
	GAS EXTRACTION WELL/HEAT EXTRACTION POINT
	CLEAN OUT
	GAS EXTRACTION WELL WITH 4" STINGER
	EXTRACTION POINT - ABANDONED
	EXTRACTION POINT - TEMPORARILY DECOMMISSIONED
	CONTAINMENT SUMP PUMP STATION FOR TOE STRIP DRAIN
	DOWNSLOPE STRIP DRAIN COLLECTOR 6" RISER STUB
	QUADRANT #
	POWER PANEL
	THERMOCOUPLE
	QUARRY WALL
	LEACHATE COLLECTION PIPING
	DUAL CONTAINED LGS FORCEMAIN (SIZE VARIES)
	DUAL CONTAINED PERIMETER FORCEMAIN (SIZE VARIES)
	LEACHATE COLLECTION PIPING (SIZE VARIES)
	TOE DRAIN
	4" PERFORATED TRENCH DRAIN
	BUBBLE SUCKER
	AIR LINE (PRESSURIZED BELOW GROUND)
	BURIED LFG COLLECTION PIPING (SIZE VARIES)
	2" ABOVE GROUND LFG COLLECTION LATERAL PIPING
	4" ABOVE GROUND LFG COLLECTION LATERAL PIPING
	6" ABOVE GROUND LFG COLLECTION LATERAL PIPING
	8" ABOVE GROUND LFG COLLECTION LATERAL PIPING
	10" ABOVE GROUND LFG COLLECTION LATERAL PIPING
	12" ABOVE GROUND LFG COLLECTION LATERAL PIPING
	18" ABOVE GROUND LFG COLLECTION LATERAL PIPING
	24" ABOVE GROUND LFG COLLECTION LATERAL PIPING
	2" PRESSURIZED AIR / 2" FORCEMAIN IN COMMON TRENCH
	UNDERGROUND ELECTRIC LINE
	UNDERGROUND ELECTRIC LINE
	SANITARY SEWER
	MSD DISCHARGE FORCEMAIN
	WATERMAIN
	NATURAL GAS LINE
	PROPANE GAS LINE
	FIBER OPTIC LINE
	TELEPHONE
	FENCE LINE
	INTERCEPTOR TRENCH
	HEAT EXTRACTION EFFLUENT PIPING
	HEAT EXTRACTION INFLUENT PIPING

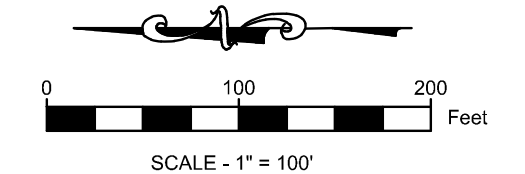

NOTES:  
 AERIAL TOPOGRAPHY AND PHOTOGRAPHY PROVIDED BY COOPER AERIAL SURVEYS CO. AND IS DATED DECEMBER 9, 2020.

DISCLAIMER:  
 THE EXISTENCE AND APPROXIMATE LOCATION OF UTILITIES KNOWN TO EXIST, AS SHOWN ON THESE DRAWINGS ARE BASED ON THE BEST INFORMATION PROVIDED TO FEI AT THE TIME OF THIS SUBMITTAL. THIS INFORMATION HAS BEEN PROVIDED TO FEI AS-IS AND FEI EXPRESSLY DISCLAIMS ANY REPRESENTATION OR WARRANTY AS TO THE COMPLETENESS OR ACCURACY OF THE INFORMATION FOR ANY USE. IT IS THE RESPONSIBILITY OF ANY PARTIES PERFORMING WORK TO VERIFY THE EXISTENCE, LOCATION AND STATUS OF ANY FACILITY. SUCH VERIFICATION INCLUDES DIRECT CONTACT WITH THE LISTED UTILITIES.

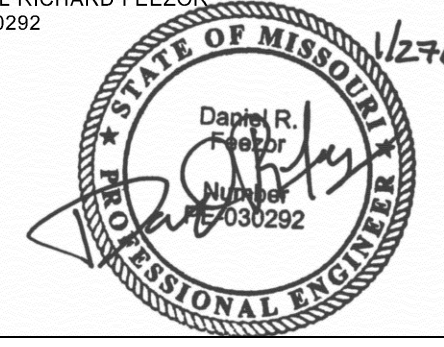

PROJECT	BRIDGETON LANDFILL 2020 Q4 INFRASTRUCTURE SUBMITTAL BRIDGETON, ST. LOUIS COUNTY, MO	PREPARED FOR	BRIDGETON LANDFILL, LLC 13570 ST. CHARLES ROCK ROAD BRIDGETON, MISSOURI 63044	DESIGNED BY: AMR	APPROVED BY: DRP	DATE	DSN	APV	DRAWING #	004
DRAWING TITLE	2020 Q4 SITE INFRASTRUCTURE (UPDATES IN Q4 SHOWN IN COLOR)									
PROJECT NUMBER:	BT-130221									



**LEGEND**

○ GMP-4	SOLID WASTE BOUNDARY
● PE-20-45	GAS MONITORING PROBE
● GEW-28	PIEZOMETER MONITORING WELL
▲ ITS-1	GAS EXTRACTION WELL
● SEW-63	INTERCEPTOR TRENCH SUMP
● PEW-20	SURFACE EXTRACTION WELL
●	PERIMETER GAS EXTRACTION WELL
●	LFG ISOLATION VALVE
●	LEACHATE ISOLATION VALVE
●	FLOW METER
●	GRIT CHAMBER
●	LIFT STATION
● CT-1	CONDENSATE SUMP
● CTAC-1	CONDENSATE TRAP/HEADER CONNECTION SUMP
● LS-1	LEACHATE COLLECTION SUMP
● LS-6	HORIZONTAL COLLECTION SUMP
▲ PS-15	PERIMETER SUMP
▲ LCS-20	LEACHATE COLLECTION SUMP
● SC-81	SURFACE COLLECTOR
● TMP-9	TEMPERATURE MONITORING PROBE
● GC-3	SUBSURFACE RCP WELLS
● T-2	TRENCH SUMP
● T-7	INTERCEPTION TRENCH RISER
● T-7	PERIMETER LEACHATE SUMP
● W-1	WELL HEAD RISER
● W-1	WELL BORE BOOT
● TS-1	TRENCH SUMP
● TS-1	OVER LINER TIE IN POINT
● TS-1	GAS INTERCEPTOR WELL
● TS-1	GAS INTERCEPTOR WELL/HEAT EXTRACTION POINT
● TS-1	CLEAN OUT
● TS-1	GAS EXTRACTION WELL WITH 4" STINGER
● TS-1	EXTRACTION POINT - ABANDONED
● TS-1	EXTRACTION POINT - TEMPORARILY DECOMMISSIONED
● TS-1	CONTAINMENT SUMP PUMP STATION FOR TOE STRIP DRAIN
● TS-1	DOWNSLOPE STRIP DRAIN COLLECTOR 6" RISER STUB
● TS-1	QUADRANT #
● TS-1	POWER PANEL
● TS-1	THERMOCOUPLE
● TS-1	QUARRY WALL
● TS-1	LEACHATE COLLECTION PIPING
● TS-1	DUAL CONTAINED LFG FORCEMAIN (SIZE VARIES)
● TS-1	DUAL CONTAINED PERIMETER FORCEMAIN (SIZE VARIES)
● TS-1	LEACHATE COLLECTION PIPING (SIZE VARIES)
● TS-1	TOE DRAIN
● TS-1	4" PERFORATED TRENCH DRAIN
● TS-1	BUBBLE SUCKER
● TS-1	AIR LINE (PRESSURIZED BELOW GROUND)
● TS-1	BURIED LFG COLLECTION PIPING (SIZE VARIES)
● TS-1	2" ABOVE GROUND LFG COLLECTION LATERAL PIPING
● TS-1	4" ABOVE GROUND LFG COLLECTION LATERAL PIPING
● TS-1	6" ABOVE GROUND LFG COLLECTION LATERAL PIPING
● TS-1	8" ABOVE GROUND LFG COLLECTION LATERAL PIPING
● TS-1	10" ABOVE GROUND LFG COLLECTION LATERAL PIPING
● TS-1	12" ABOVE GROUND LFG COLLECTION LATERAL PIPING
● TS-1	18" ABOVE GROUND LFG COLLECTION HEADER PIPING
● TS-1	24" ABOVE GROUND LFG COLLECTION LATERAL PIPING
● TS-1	2" PRESSURIZED AIR / 2" FORCEMAIN IN COMMON TRENCH
● TS-1	ABOVEGROUND ELECTRIC LINE
● TS-1	UNDERGROUND ELECTRIC LINE
● TS-1	SANITARY SEWER
● TS-1	MSD DISCHARGE FORCEMAIN
● TS-1	WATERMAIN
● TS-1	NATURAL GAS LINE
● TS-1	PROPANE GAS LINE
● TS-1	FIBER OPTIC LINE
● TS-1	TELEPHONE
● TS-1	FENCE LINE
● TS-1	INTERCEPTOR TRENCH
● TS-1	HEAT EXTRACTION EFFLUENT PIPING
● TS-1	HEAT EXTRACTION INFLUENT PIPING

**NOTES:**  
 AERIAL TOPOGRAPHY AND PHOTOGRAPHY PROVIDED BY COOPER AERIAL SURVEYS CO. AND IS DATED DECEMBER 9, 2020.

**DISCLAIMER:**  
 THE EXISTENCE AND APPROXIMATE LOCATION OF UTILITIES KNOWN TO EXIST, AS SHOWN ON THESE DRAWINGS ARE BASED ON THE BEST INFORMATION PROVIDED TO FEI AT THE TIME OF THIS SUBMITTAL. THIS INFORMATION HAS BEEN PROVIDED TO FEI AS-IS AND FEI EXPRESSLY DISCLAIMS ANY REPRESENTATION OR WARRANTY AS TO THE COMPLETENESS OR ACCURACY OF THE INFORMATION FOR ANY USE. IT IS THE RESPONSIBILITY OF ANY PARTIES PERFORMING WORK TO VERIFY THE EXISTENCE, LOCATION AND STATUS OF ANY FACILITY. SUCH VERIFICATION INCLUDES DIRECT CONTACT WITH THE LISTED UTILITIES.

**FEZZOR ENGINEERING, INC.**  
 3377 Hollenberg Dr. Bridgeton, MO 63044, Ph: 217-483-3118  
 Missouri State Certificate Of Authority #: E-200912213

**BRIDGETON LANDFILL, LLC.**  
 13570 ST. CHARLES ROCK ROAD  
 BRIDGETON, MISSOURI 63044

**2020 Q4 SITE INFRASTRUCTURE (REMOVED IN Q4 SHOWN IN RED)**

SCALE - 1" = 100'

PROJECT	BRIDGETON LANDFILL 2020 Q4 INFRASTRUCTURE SUBMITTAL BRIDGETON, ST. LOUIS COUNTY, MO	PREPARED FOR	BRIDGETON LANDFILL, LLC. 13570 ST. CHARLES ROCK ROAD BRIDGETON, MISSOURI 63044	DESIGNED BY: AMR	APPROVED BY: DRF	DRAWING #	<b>005</b>
DRAWING TITLE	2020 Q4 SITE INFRASTRUCTURE (REMOVED IN Q4 SHOWN IN RED)			DATE	DATE	DATE	DATE
PROJECT NUMBER	BT-130211			DATE	DATE	DATE	DATE